

FLOOR PLAN GENERAL NOTES

1. WALLS FOR WHICH THE DESIGNER HAS NOT SPECIFIED A FINISH SHALL BE FINISHED WITH A FINISH AS SHOWN ON THE DRAWINGS.
2. FINISHES FOR WHICH THE DESIGNER HAS NOT SPECIFIED A FINISH SHALL BE FINISHED WITH A FINISH AS SHOWN ON THE DRAWINGS.
3. ALL FINISHES ARE TO BE OF EQUAL QUALITY AND SHALL BE INSTALLED IN ACCORDANCE WITH THE MANUFACTURER'S RECOMMENDATIONS.
4. WALLS TO BE CONSTRUCTED IN ACCORDANCE WITH THE MANUFACTURER'S RECOMMENDATIONS.
5. FINISHES FOR WHICH THE DESIGNER HAS NOT SPECIFIED A FINISH SHALL BE FINISHED WITH A FINISH AS SHOWN ON THE DRAWINGS.
6. FINISHES FOR WHICH THE DESIGNER HAS NOT SPECIFIED A FINISH SHALL BE FINISHED WITH A FINISH AS SHOWN ON THE DRAWINGS.
7. FINISHES FOR WHICH THE DESIGNER HAS NOT SPECIFIED A FINISH SHALL BE FINISHED WITH A FINISH AS SHOWN ON THE DRAWINGS.
8. FINISHES FOR WHICH THE DESIGNER HAS NOT SPECIFIED A FINISH SHALL BE FINISHED WITH A FINISH AS SHOWN ON THE DRAWINGS.
9. FINISHES FOR WHICH THE DESIGNER HAS NOT SPECIFIED A FINISH SHALL BE FINISHED WITH A FINISH AS SHOWN ON THE DRAWINGS.
10. FINISHES FOR WHICH THE DESIGNER HAS NOT SPECIFIED A FINISH SHALL BE FINISHED WITH A FINISH AS SHOWN ON THE DRAWINGS.
11. FINISHES FOR WHICH THE DESIGNER HAS NOT SPECIFIED A FINISH SHALL BE FINISHED WITH A FINISH AS SHOWN ON THE DRAWINGS.
12. FINISHES FOR WHICH THE DESIGNER HAS NOT SPECIFIED A FINISH SHALL BE FINISHED WITH A FINISH AS SHOWN ON THE DRAWINGS.
13. FINISHES FOR WHICH THE DESIGNER HAS NOT SPECIFIED A FINISH SHALL BE FINISHED WITH A FINISH AS SHOWN ON THE DRAWINGS.
14. FINISHES FOR WHICH THE DESIGNER HAS NOT SPECIFIED A FINISH SHALL BE FINISHED WITH A FINISH AS SHOWN ON THE DRAWINGS.
15. FINISHES FOR WHICH THE DESIGNER HAS NOT SPECIFIED A FINISH SHALL BE FINISHED WITH A FINISH AS SHOWN ON THE DRAWINGS.
16. FINISHES FOR WHICH THE DESIGNER HAS NOT SPECIFIED A FINISH SHALL BE FINISHED WITH A FINISH AS SHOWN ON THE DRAWINGS.
17. FINISHES FOR WHICH THE DESIGNER HAS NOT SPECIFIED A FINISH SHALL BE FINISHED WITH A FINISH AS SHOWN ON THE DRAWINGS.

CODED NOTE LEGEND

1. ALUMINUM SURFACES
2. PLUMBING FIXTURES, SEE PLUMBING DRAWINGS
3. MECHANICAL EQUIPMENT, SEE MECHANICAL DRAWINGS
4. DEMOUNTABLE GLASS WALL AND DOOR SYSTEM
5. CASEWORK, SEE ELEVATIONS FOR DETAILS
6. DETAILS
7. FINISHES TO BE SHOWN ON SHEET SEE SHEET 6001-001
8. FINISHES TO BE SHOWN ON SHEET SEE SHEET 6001-002
9. FINISHES TO BE SHOWN ON SHEET SEE SHEET 6001-003
100. FINISHES TO BE SHOWN ON SHEET SEE SHEET 6001-094


RATED WALL LEGEND

TYPE	DESCRIPTION
1	1 HOUR FIRE RATED PARTITION TO DECK
2	2 HOUR FIRE RATED PARTITION TO DECK
3	3 HOUR FIRE RATED PARTITION TO DECK
4	4 HOUR FIRE RATED PARTITION TO DECK
5	5 HOUR FIRE RATED PARTITION TO DECK
6	6 HOUR FIRE RATED PARTITION TO DECK
7	7 HOUR FIRE RATED PARTITION TO DECK
8	8 HOUR FIRE RATED PARTITION TO DECK
9	9 HOUR FIRE RATED PARTITION TO DECK
10	10 HOUR FIRE RATED PARTITION TO DECK

NO.	DATE	CHANGE DESCRIPTION
1	06/08/2022	ISSUED FOR PERMIT
2	06/08/2022	REVISED PER COMMENTS
3	06/08/2022	REVISED PER COMMENTS
4	06/08/2022	REVISED PER COMMENTS
5	06/08/2022	REVISED PER COMMENTS
6	06/08/2022	REVISED PER COMMENTS
7	06/08/2022	REVISED PER COMMENTS
8	06/08/2022	REVISED PER COMMENTS
9	06/08/2022	REVISED PER COMMENTS
10	06/08/2022	REVISED PER COMMENTS

CMHA ADMINISTRATIVE BUILDING RENOVATION
 COLUMBUS METROPOLITAN COLLEGE, OH 43210
 COLUMBIAN METROPOLITAN COLLEGE AUTHORITY
 300 SPRUCE STREET
 SUITE 300
 COLUMBUS, OHIO 43215
 PHONE: (614) 461-4684
 FAX: (614) 282-8681
 MOON/NOLAN

DATE	06/08/2022
DRAWN BY	WJK
CHECKED BY	XXX
SCALE	2/328
A102	
CONFIRMED SET #11	

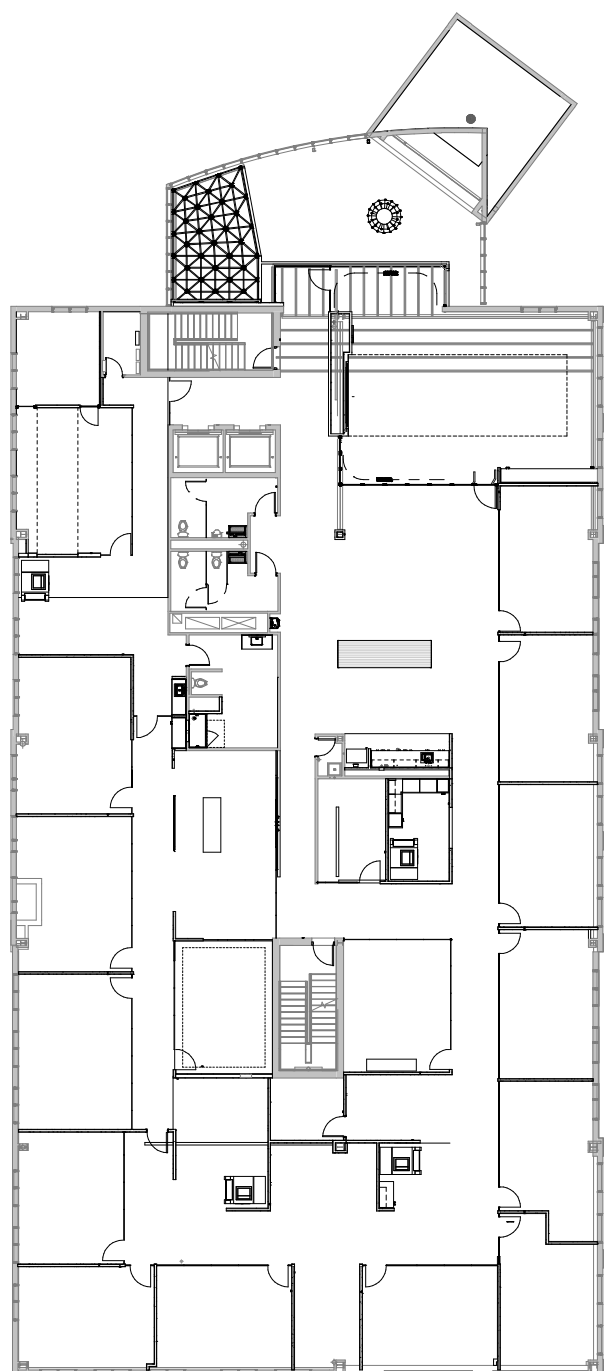

1 OVERALL SECOND FLOOR PLAN
 1/8" = 1'-0"